


----- EXISTANT INSTALLATION

——— NEW INSTALLATION

- - - - - FUTURE INSTALLATION

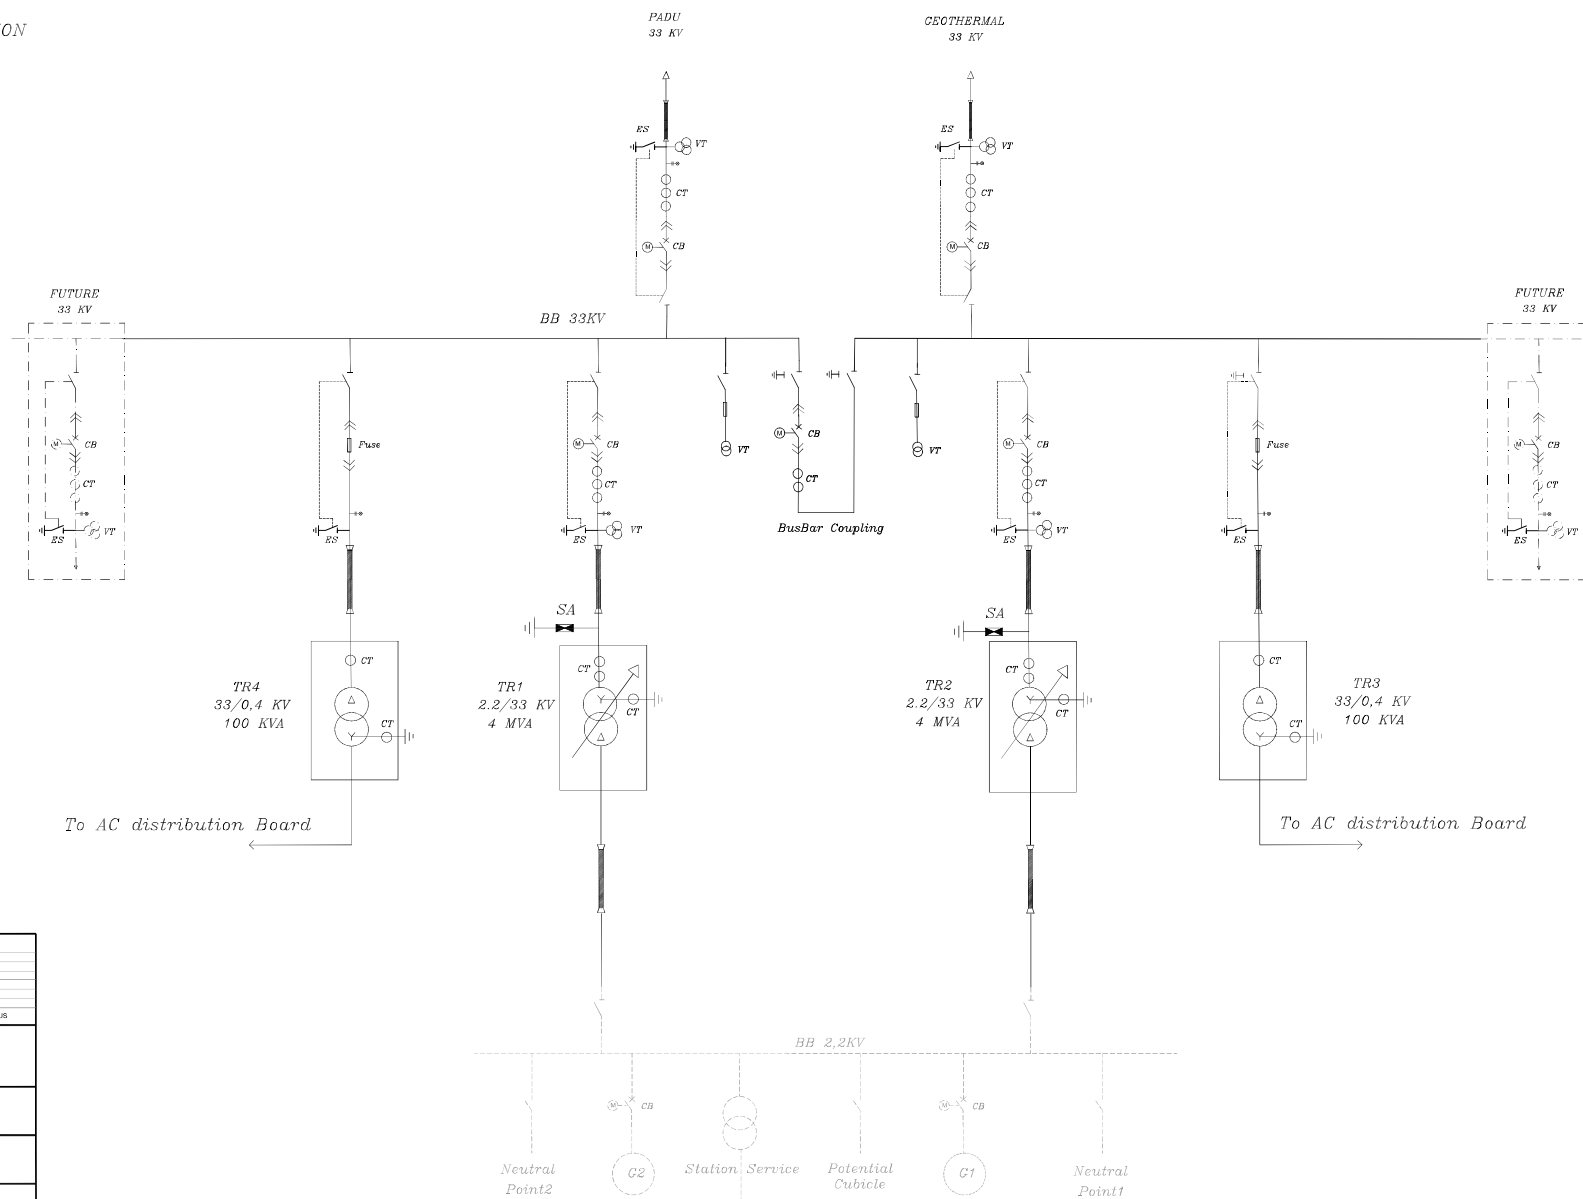

REVISIONS							
03	Third Revision	03-03-2024	03-03-2024				
02	Second Revision	03-03-2023	03-03-2023				
01	First Submission	16-03-2023	23-03-2023				
Rev. No	DETAILS	DATE PREPARED	DATE CHECKED				
Owner							
PROJECT				Dominica Geothermal Development Company LTD			
Consultant							
Scale: 1/100 Size: A3				Document Title:			
				Trafalgar Substation			
				Single Line Diagram			
				DWG No. DDGC-EL-TRAF-SLD-001			
				SHEET 1 of 1			
				REV 03			