
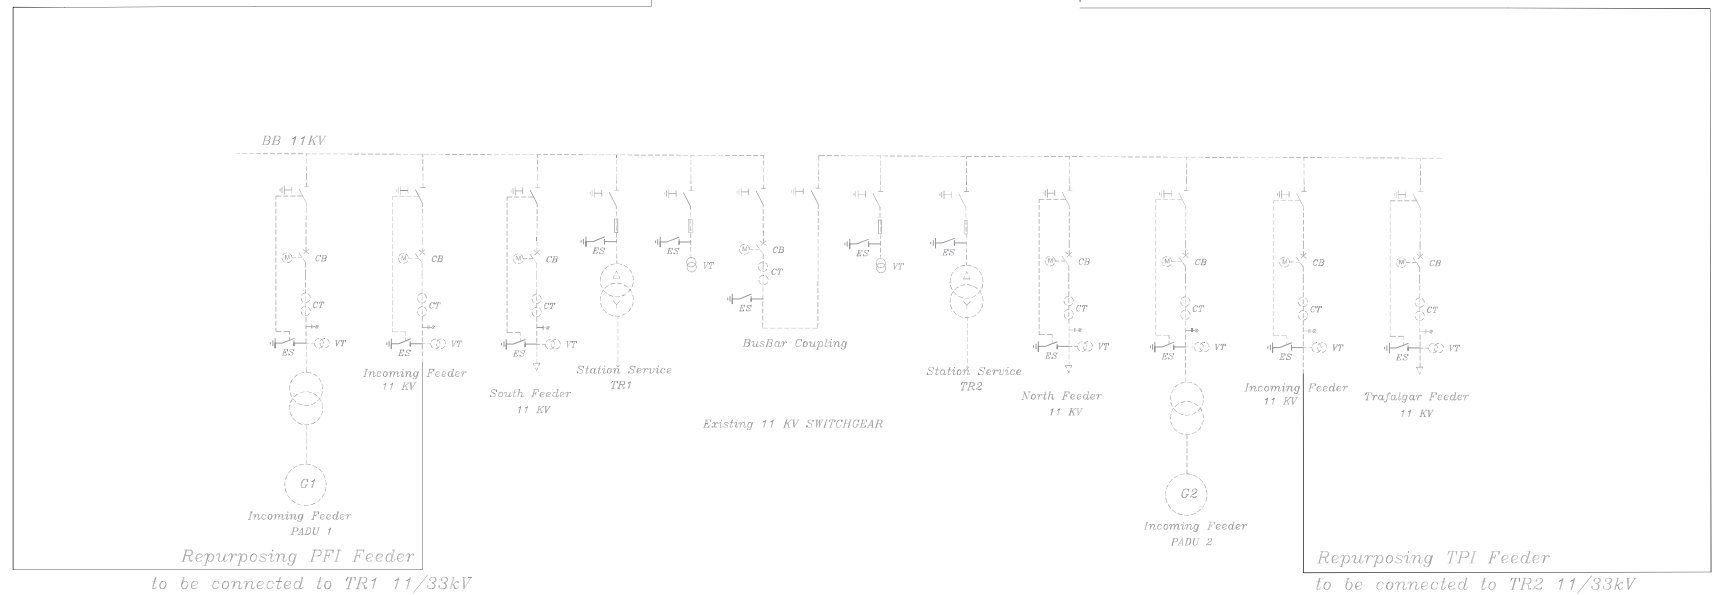


----- EXISTANT INSTALLATION

———— NEW INSTALLATION

- - - - FUTURE INSTALLATION

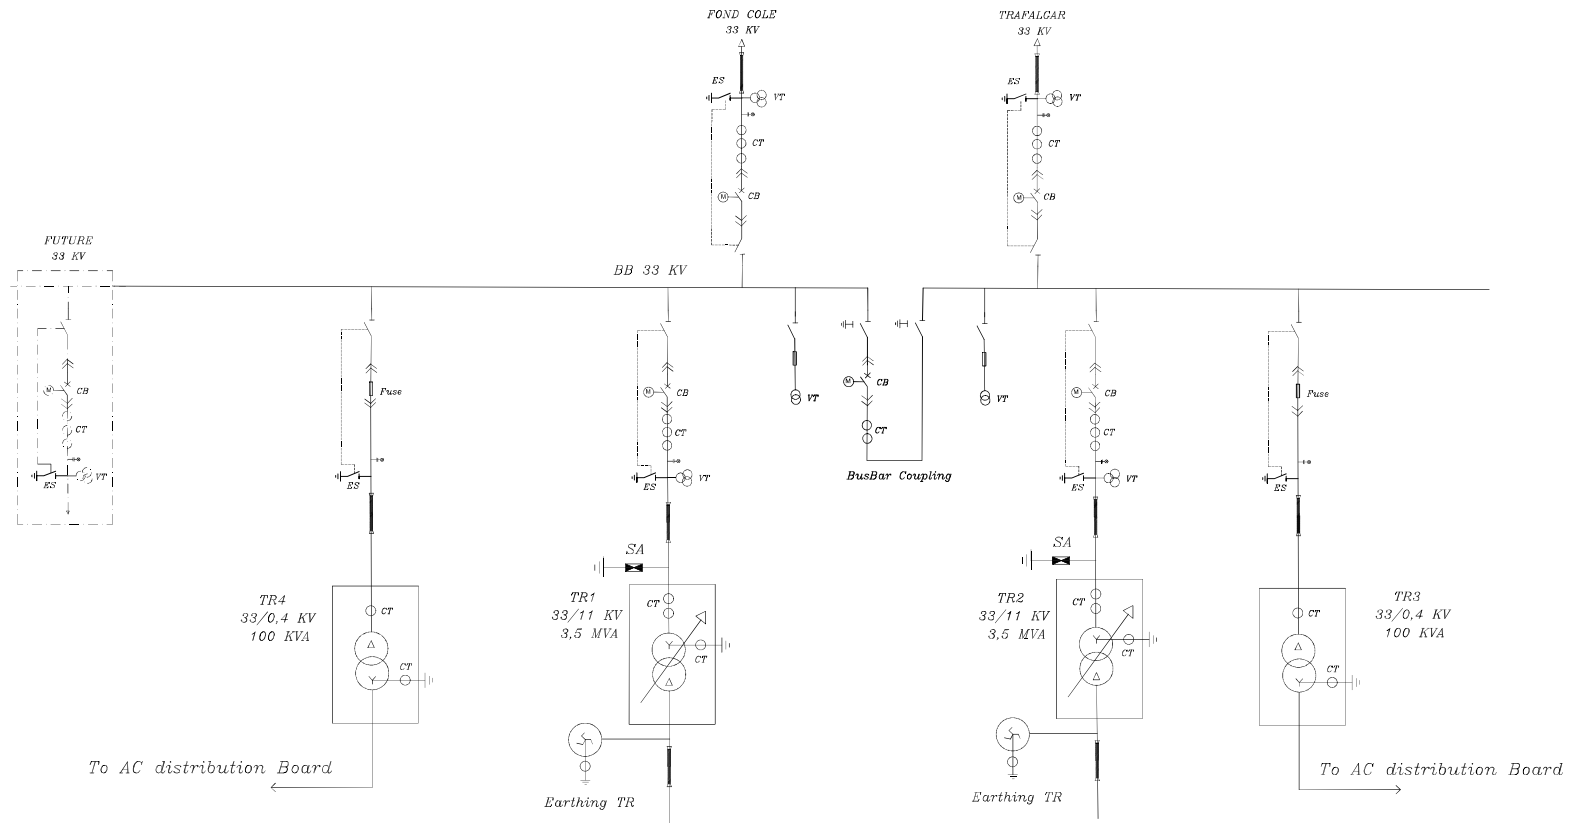

REVISIONS					
REV. NO.	DETAILS	DATE PREPARED	DATE CHECKED	STATUS	
03	Third Revision	03-03-2024	03-03-2024		
02	Second Revision	06-09-2023	06-09-2023		
01	First submission	16-02-2023	24-02-2023		
Owner					
PROJECT	Dominica Geothermal Development Company LTD				
Consultant					
Scale	1/100 (Size A0)	Document Title:			
Prepared	16-02-2023	Name	Signature	Padu Substation 33/11 KV	
Checked	23-02-2023	C.Y.		Single Line Diagram	
Approved	02-03-2023	A.Z.		DWG No.	SHEET REV
				DDDC-EL-PADU-SLD-001	1 of 1 03