

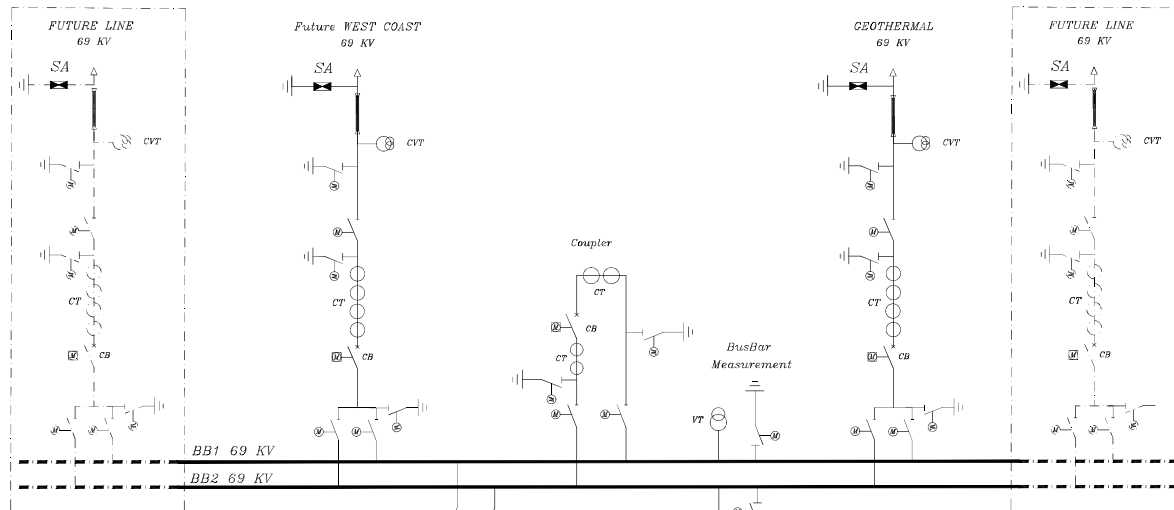
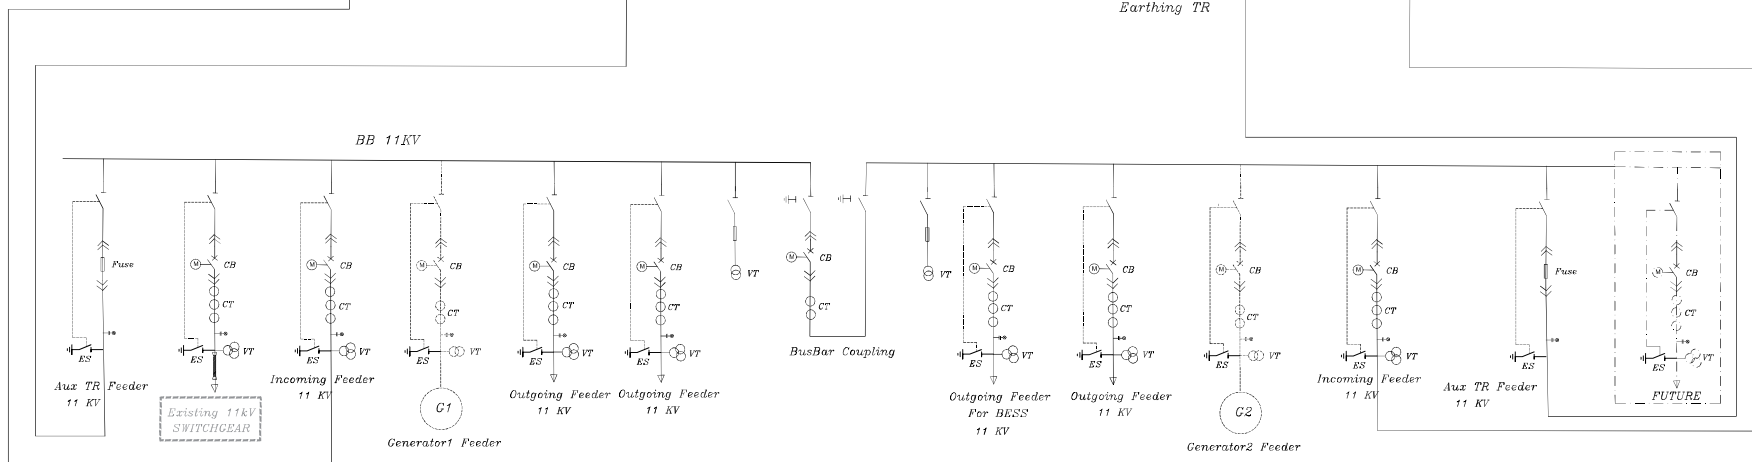
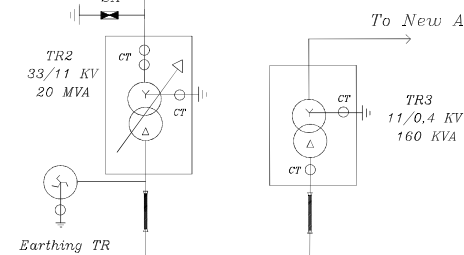
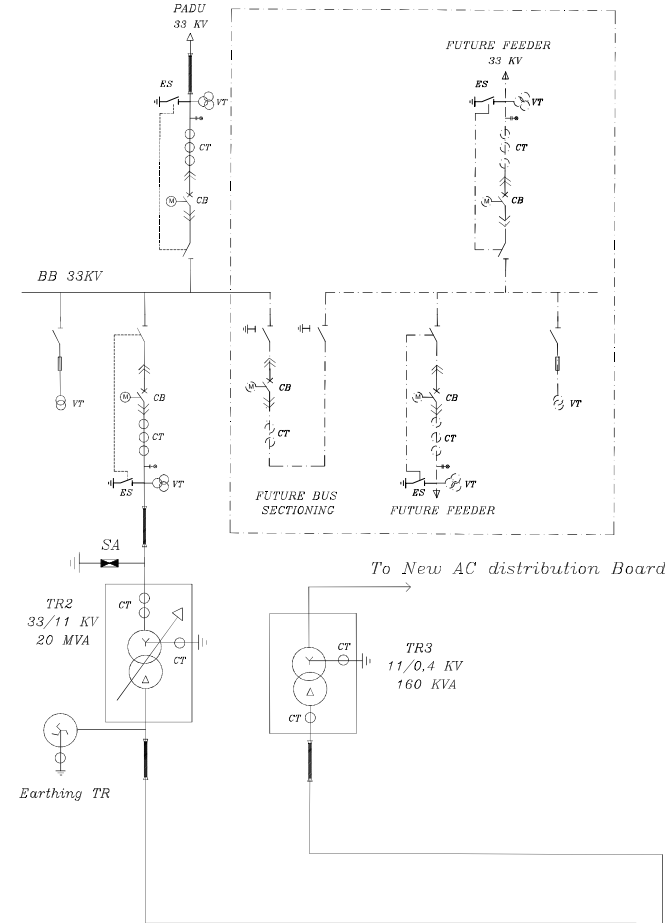


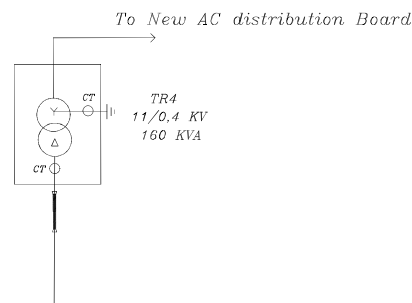

----- EXISTANT INSTALLATION
 ——— NEW INSTALLATION
 - - - - - FUTURE INSTALLATION

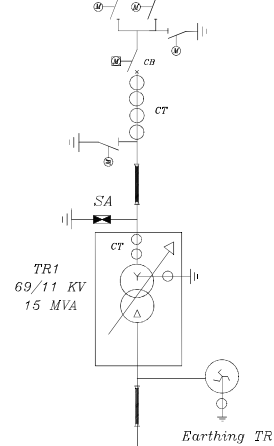

REVISIONS					
03	Third Revision	03-03-2024	03-03-2024		
02	Second Revision	08-03-2023	08-03-2023		
01	First Submission	16-02-2023	25-02-2023		
Rev. No	DETAILS	DATE PREPARED	DATE CHECKED		STATUS
Owner					
PROJECT					
Dominica Geothermal Development Company LTD					
Consultant					
SOFRECO					
Scale: 1/100 [Size: A0]					
Document Title: Fond Cole Substation					
Single Line Diagram					
Prepared	16-03-2023	R.M.			
Checked	23-02-2023	C.Y.			
Approved	02-03-2023	A.Z.			
DWG No. DGDG-EL-FC-SLD-001				SHEET	REV
				1 of 1	03