


----- EXISTANT INSTALLATION

———— NEW INSTALLATION

----- FUTURE INSTALLATION

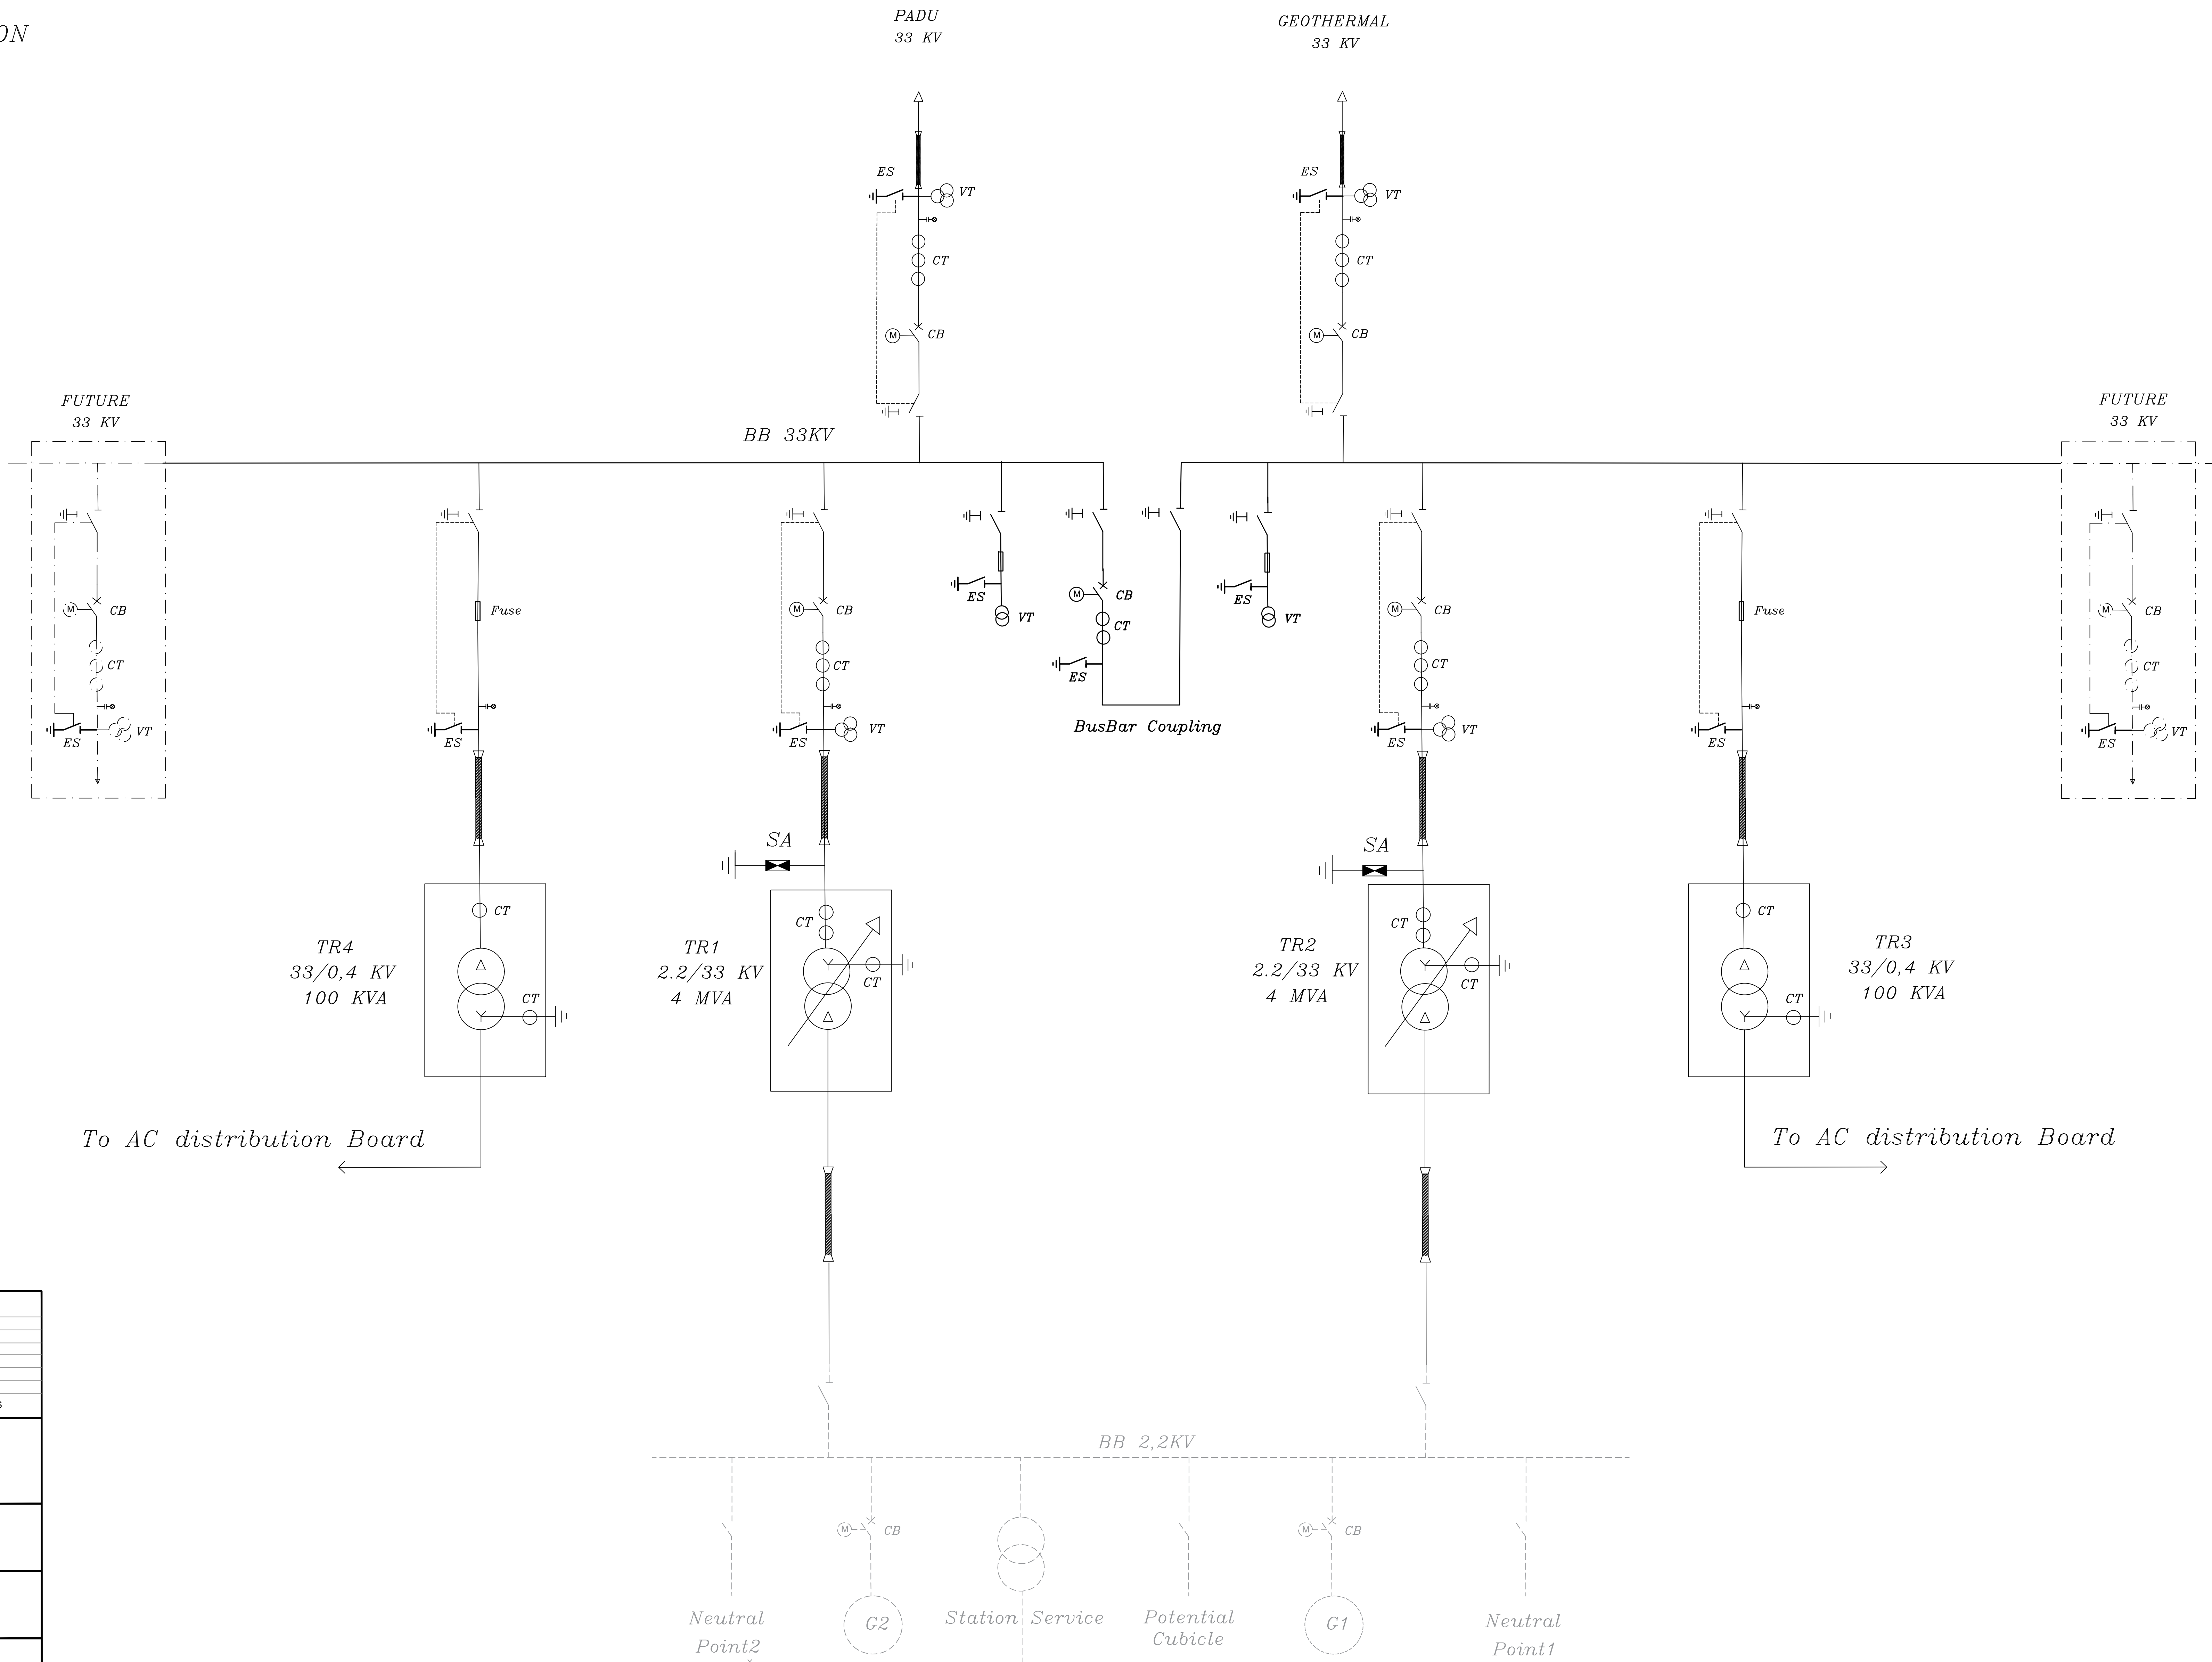

REVISIONS				
	02	Second Revision	08-09-2023	08-09-2023
	01	First submission	16-02-2023	23-02-2023
Rev. No	DETAILS	DATE PREPARED	DATE CHECKED	STATUS
Owner				
 Dominica Geothermal Development Company Limited A Promoting a New Generation				
PROJECT				
Dominica Geothermal Development Company LTD				
Consultant				
 SOFRECO				
Scale 1/100 Size A0				
Document Title:				
Trafalgar Substation				
Single Line Diagram				
Prepared		Date		Signature
Checked		Date		Signature
Approved		Date		Signature
DWG No.		SHEET		REV
DSDC-EL-TRAF-SLD-001		1 of 1		02