
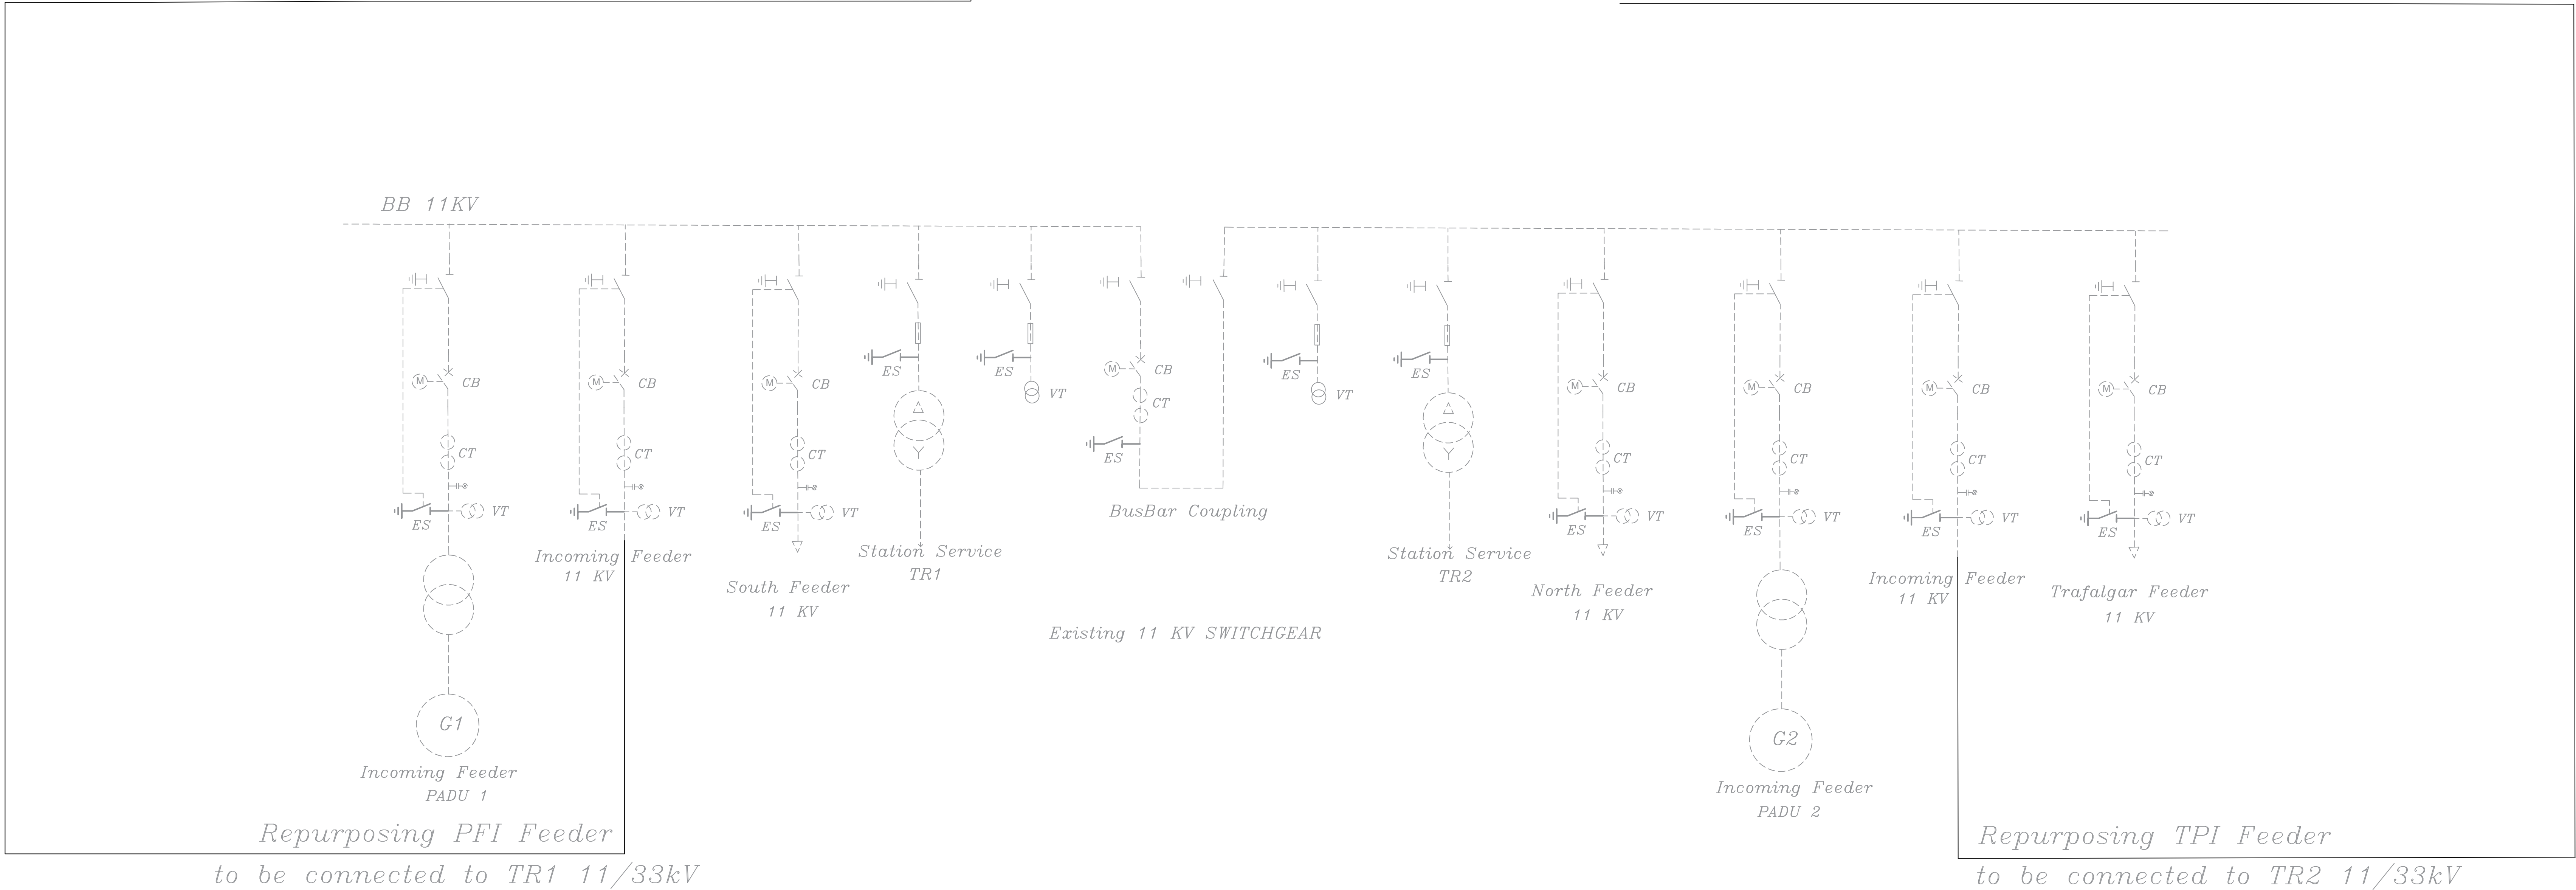


----- EXISTANT INSTALLATION
———— NEW INSTALLATION
----- FUTURE INSTALLATION

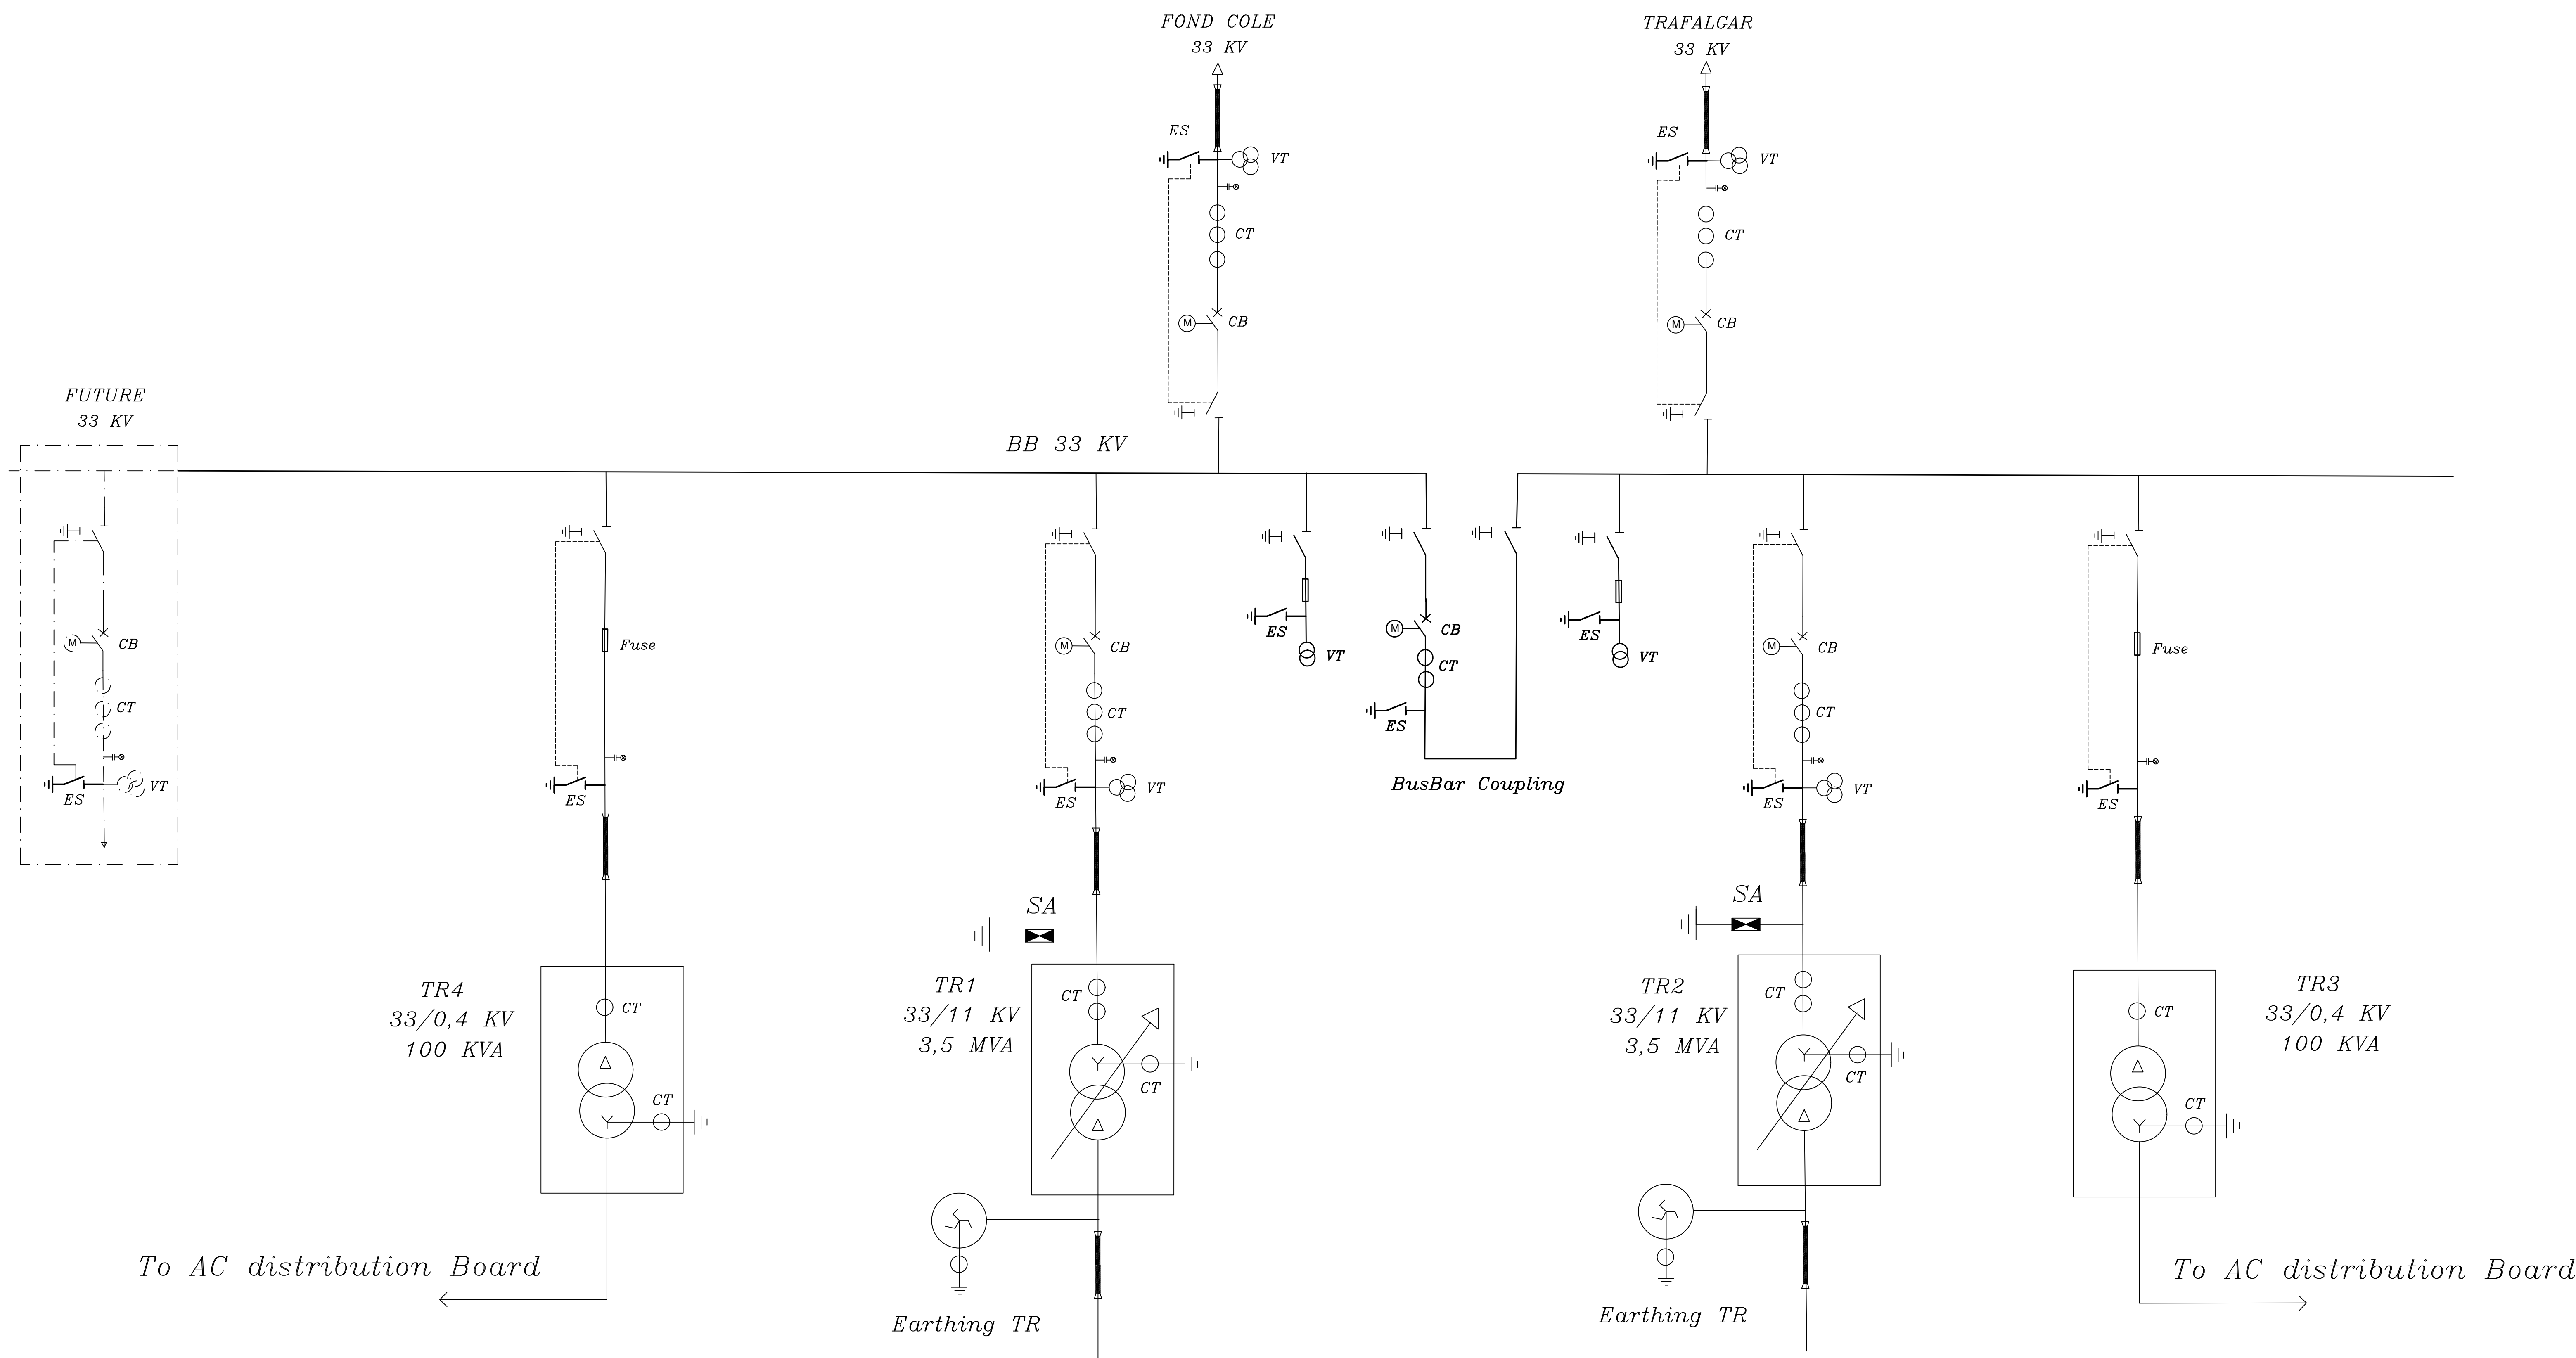

REVISIONS					
	02	Second Revision	08-09-2023	08-09-2023	
	01	First submission	16-02-2023	23-02-2023	
Rev. No	DETAILS	DATE PREPARED	DATE CHECKED	STATUS	
Owner					
 Dominica Geothermal Development Company Limited Geothermal & Solar Corporation					
PROJECT					
Dominica Geothermal Development Company LTD					
Consultant					
 SOFRECO					
Scale	1/100	Size	A0	Document Title:	
	Date	Name	Signature	Padu Substation 33/11 KV Single Line Diagram	
Prepared	16-02-2023	R.M			
Checked	23-02-2023	C.Y			
Approved	02-03-2023	A.Z			
			DWG No.	SHEET	REV
			DGDC-EL-PADU-SLD-001	1 of 1	02